


RenderViewpoint_1

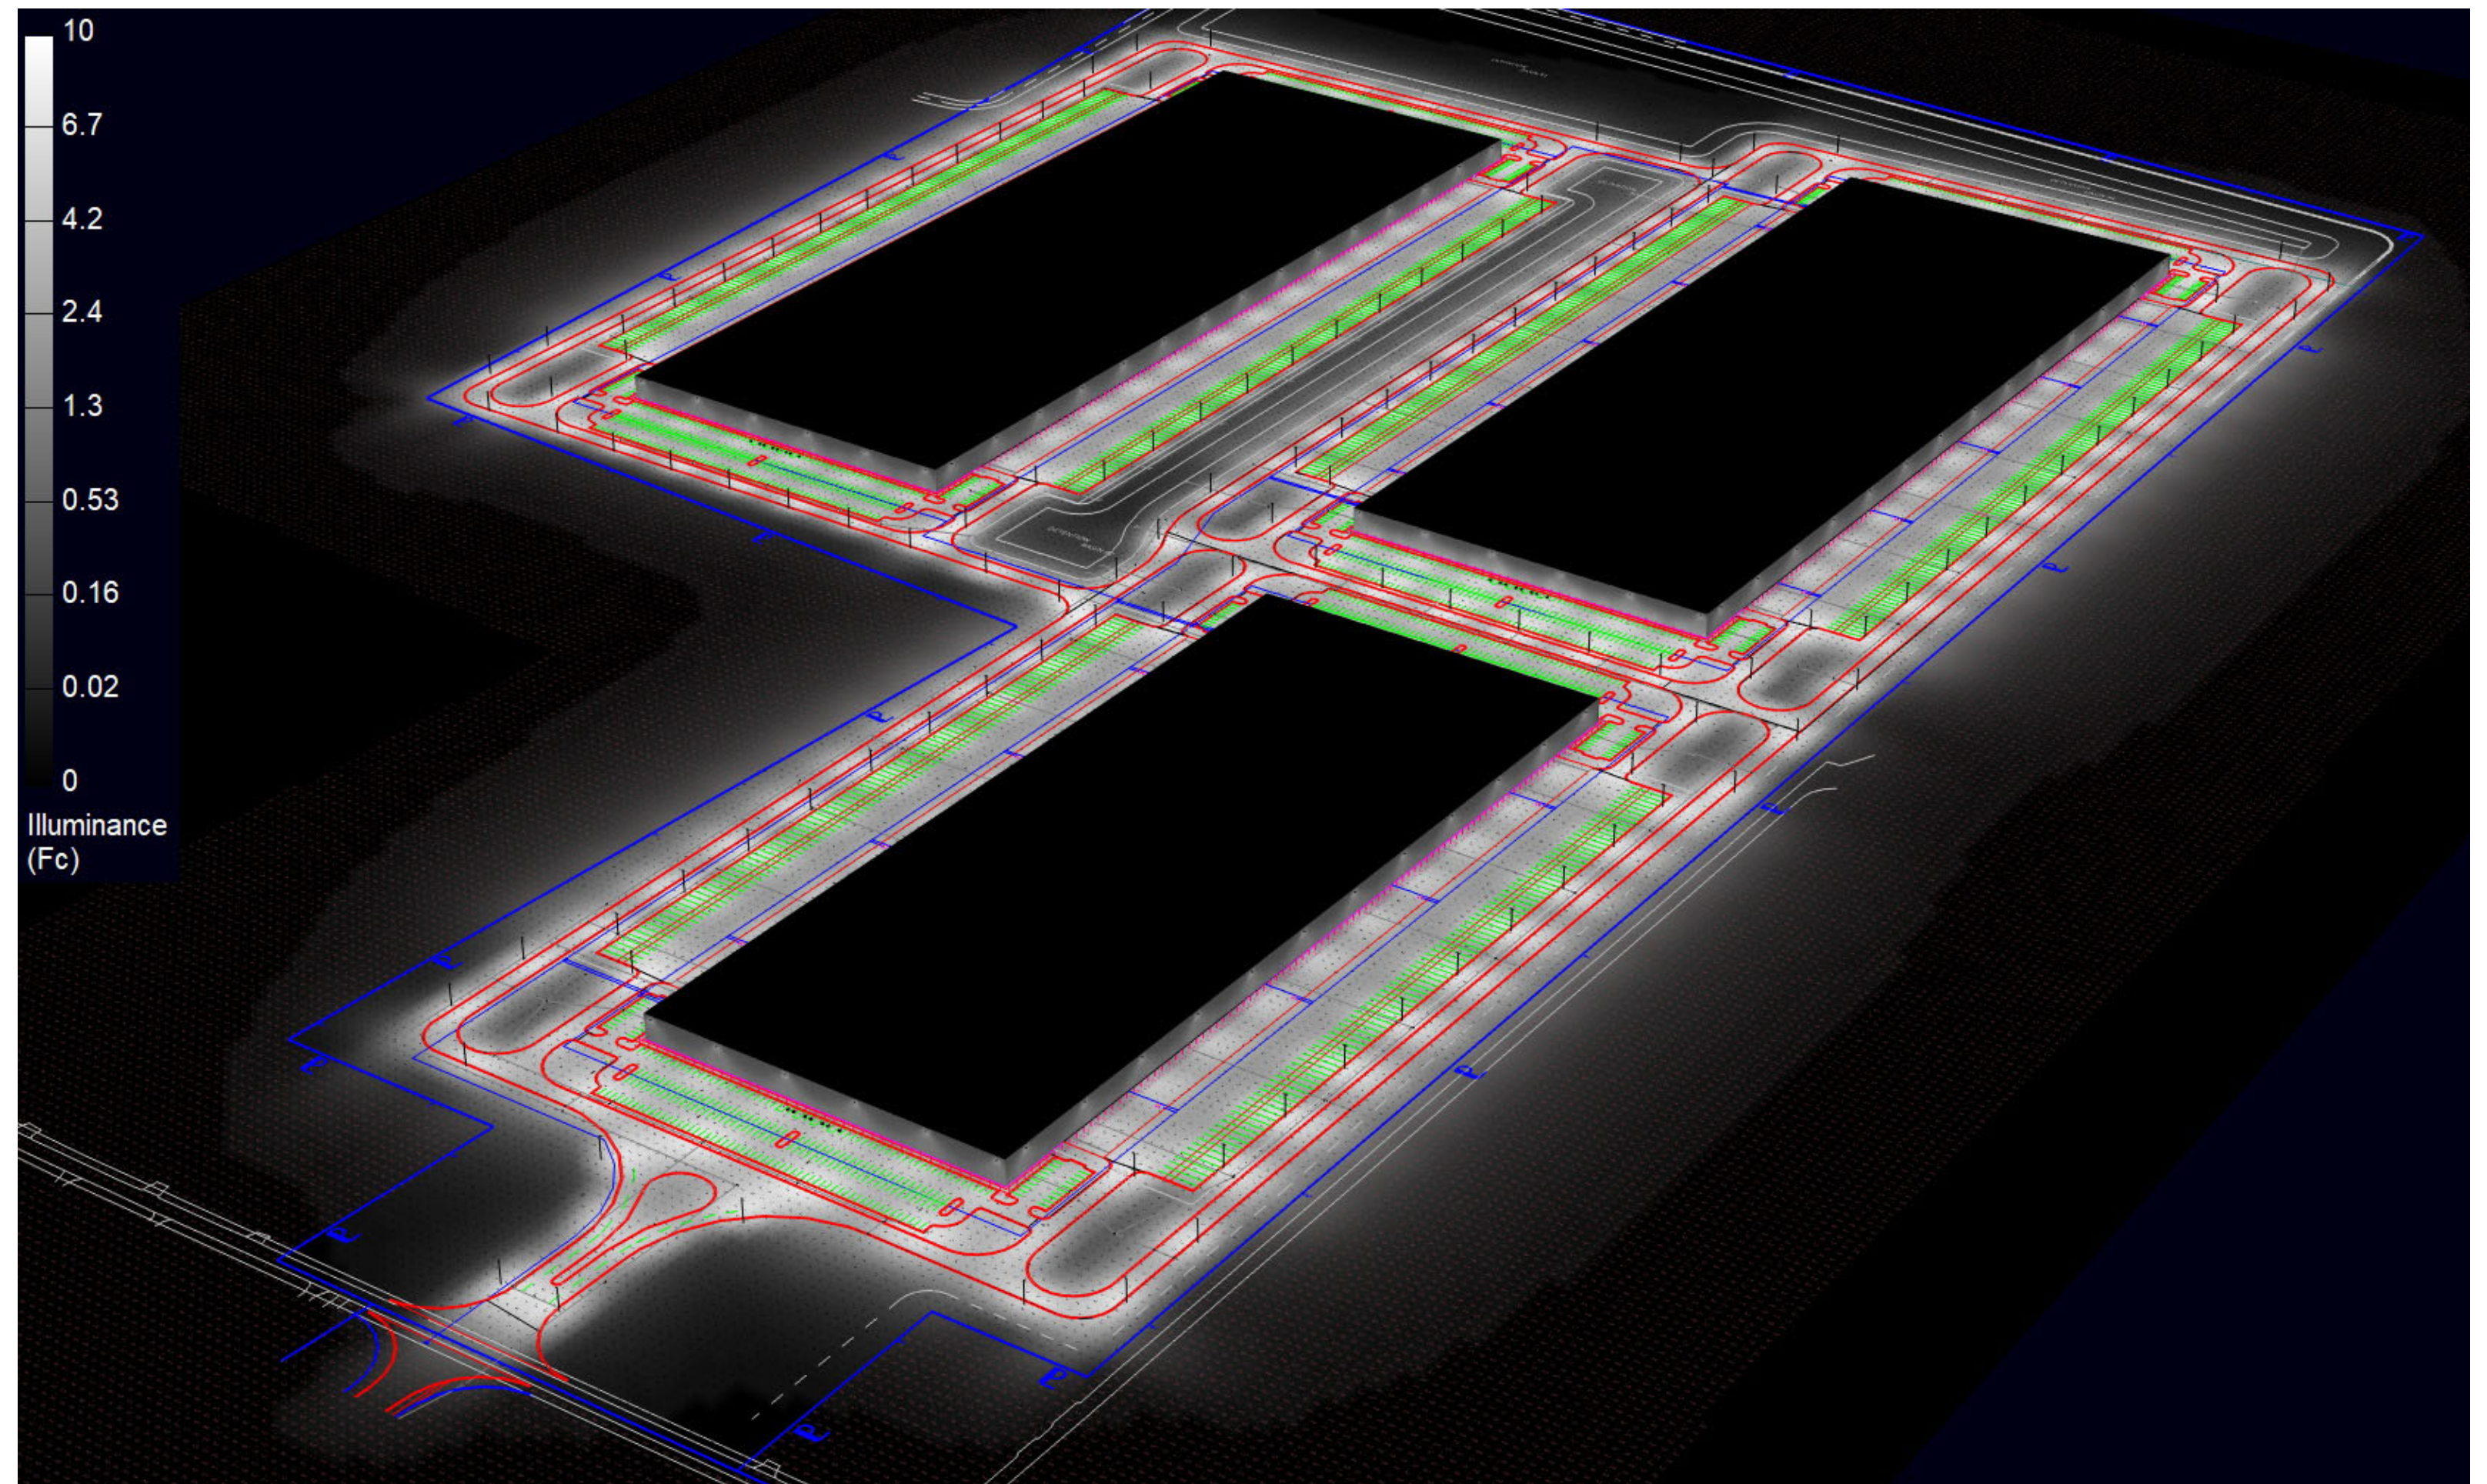

RenderViewpoint_2

The Lighting Analysis, Layout Energy Analysis and/or Visual Simulation ("Lighting Design") provided by RAB Lighting Inc. ("RAB") is based on design parameters and information supplied by others. These design parameters and information have not been field verified by RAB and therefore actual measured results may vary from the actual field conditions. RAB recommends that design parameters and other information be field verified to reduce variation. RAB neither warrants, either implied or stated with regard to actual measured light levels or energy consumption levels as compared to those illustrated by the Lighting Design. RAB neither warrants, either implied or stated, nor represents the appropriateness, completeness or suitability of the Lighting Design as compliant with any applicable regulatory code requirements, or as a basis for any construction documents for informational purposes and is not intended for construction nor as being part of a project's construction documentation package.

Scale: as noted	PROJECT # 192304
Date: 4/13/2022	CASE # 00844890
Filename: DHL - Ashville 00844890A.AGI	
Drawn By: Donald G. Andrews	

Job Name: DHL - Ashville Ashville, OH Lighting Layout Version A

Prepared For:
Pollart Electrical Sales Inc.
1231 Ford Road
Bensalem, PA 19020
Tel: 888-839-1591

RAB
170 Ludlow Avenue, Northvale, NJ 07647
888-722-1000 • rablighting.com

Filename: C:\Job Files\Pollart\DHL - Ashville\DHL - Ashville 00844890A.AGI